

# American Medical Group Association

March 8 - 10, 2018

## Phoenix Convention Center\_North Building Exhibition Hall A & B\_300 Level Phoenix, AZ



Show Information	
Show Name	American Medical Group Association
Show Dates	3/8/2018 - 3/10/2018
Move-In	3/7/2018
Job #	P110050318
AE	Tara Szatkowski

Inventory as of 01/22/2018

Dimension	Size	Qty	SqFt
10'x10'	100	118	11,800
10'x20'	200	15	3,000
20'x20'	400	4	1,600
20'x30'	600	1	600
Totals:		138	17,000

Banquet Seating for 840  
Theater Seating for 50

Icon	Floor Plan Legend
FE	Fire Extinguisher
FS	Fire Strobe
FHC	Fire Hose Cabinet
.	?
.	?

Venue Info	
Building Name	Phoenix Convention Center
Hall	Hall A & B
Floor	300 Level
Address	100 N 3rd St Phoenix, AZ 85004

Drawing Information	
File Path	J:\SES\Floorplans\01_SES_SHOW\FLOORPLANS\0318\03_March
File Name	03_American Medical Group Association_P110050318_Floorplan.dwg
Drawn By	Ron Schumacher
Last Saved	1/22/2018 3:46 PM
Saved By	Rperry
Tab	Floorplan
Paper Size	ANSI full bleed B (11.00 x 17.00 Inches)
Scale	1/16" = 1'-0"


1531 Carroll Drive NW  
Atlanta, GA 30318  
(v) 404-720-8600  
(f) 404-720-8750

1/22/2018 3:46 PM RACHEL PERRY

**SUBJECT TO  
FIRE MARSHAL APPROVAL**



PCC NORTH BUILDING

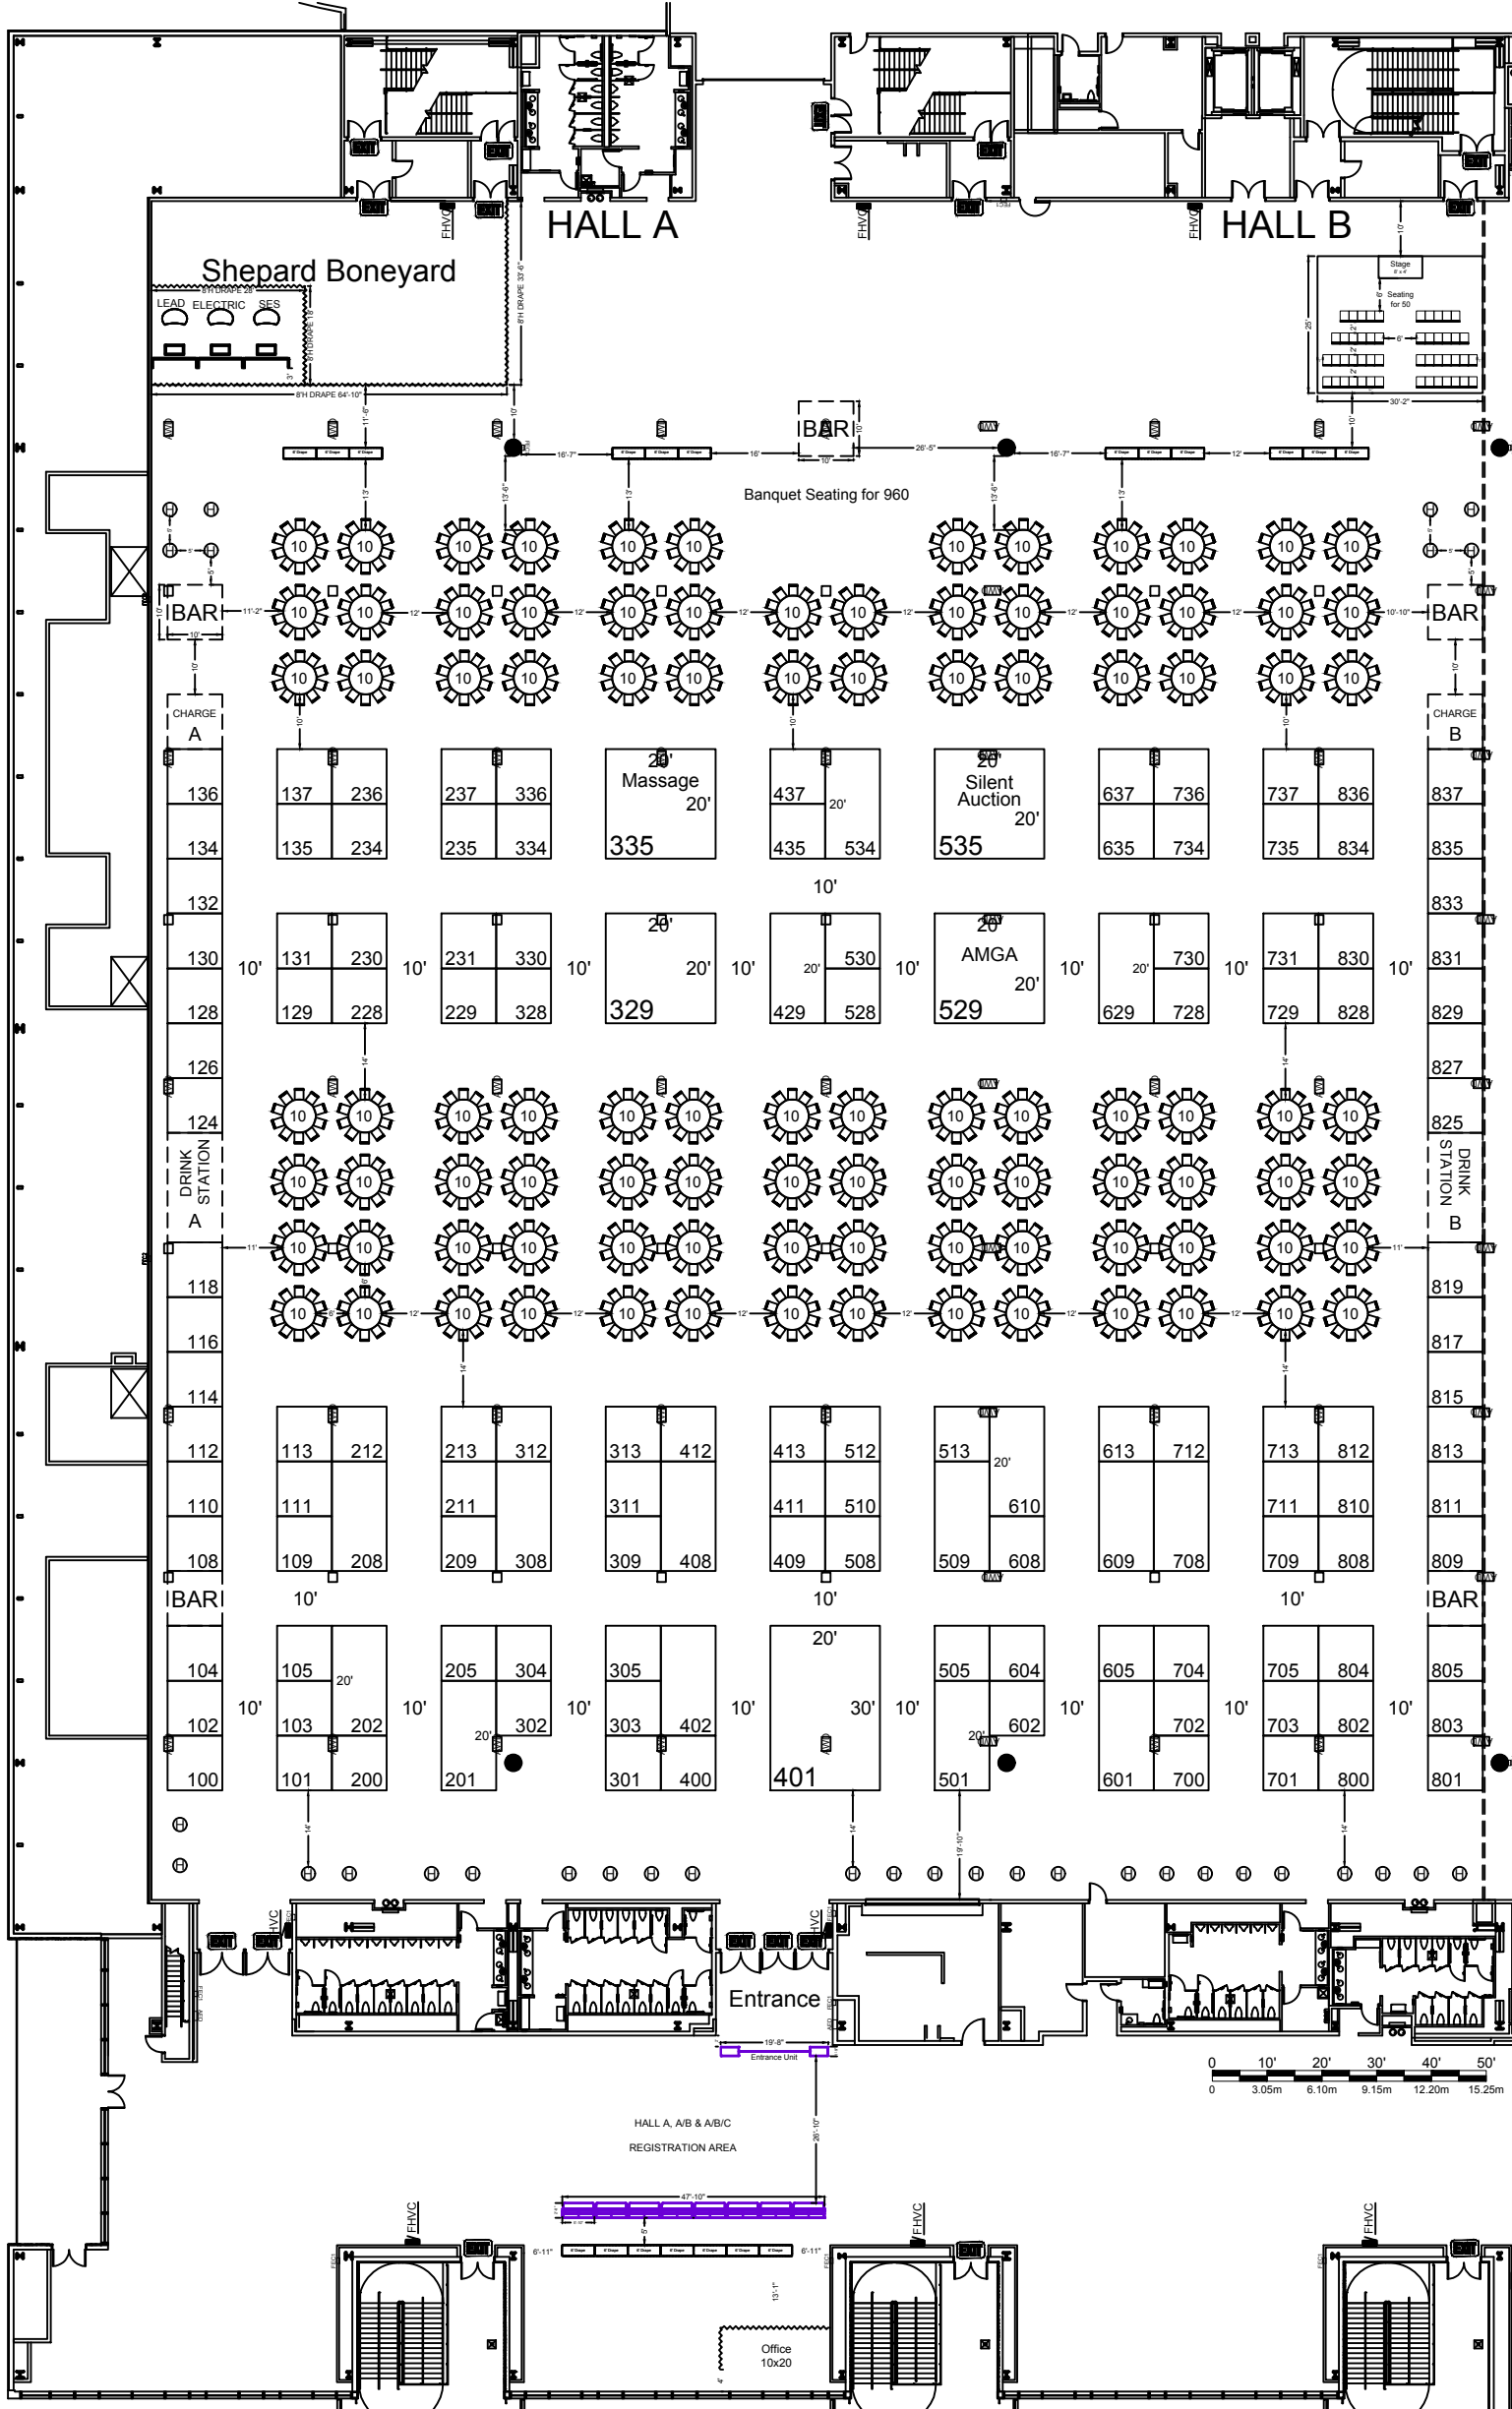

Shepard Exposition Services has made every effort to ensure the accuracy of all information contained on this floor plan. However, no warranties, either expressed or implied, are made with respect to this floor plan. If the location of building columns, utilities or other architectural components of the facility is a sole responsibility of the exhibitor/show management to physically inspect the facility to verify all dimensions and locations.